

▲最高高さ

▼梁天

▼2FL

▼1FL

▼GL

1000

3035

7220

2520

665

1800

1800

7200

1800

1800


①

②

③

④

⑤

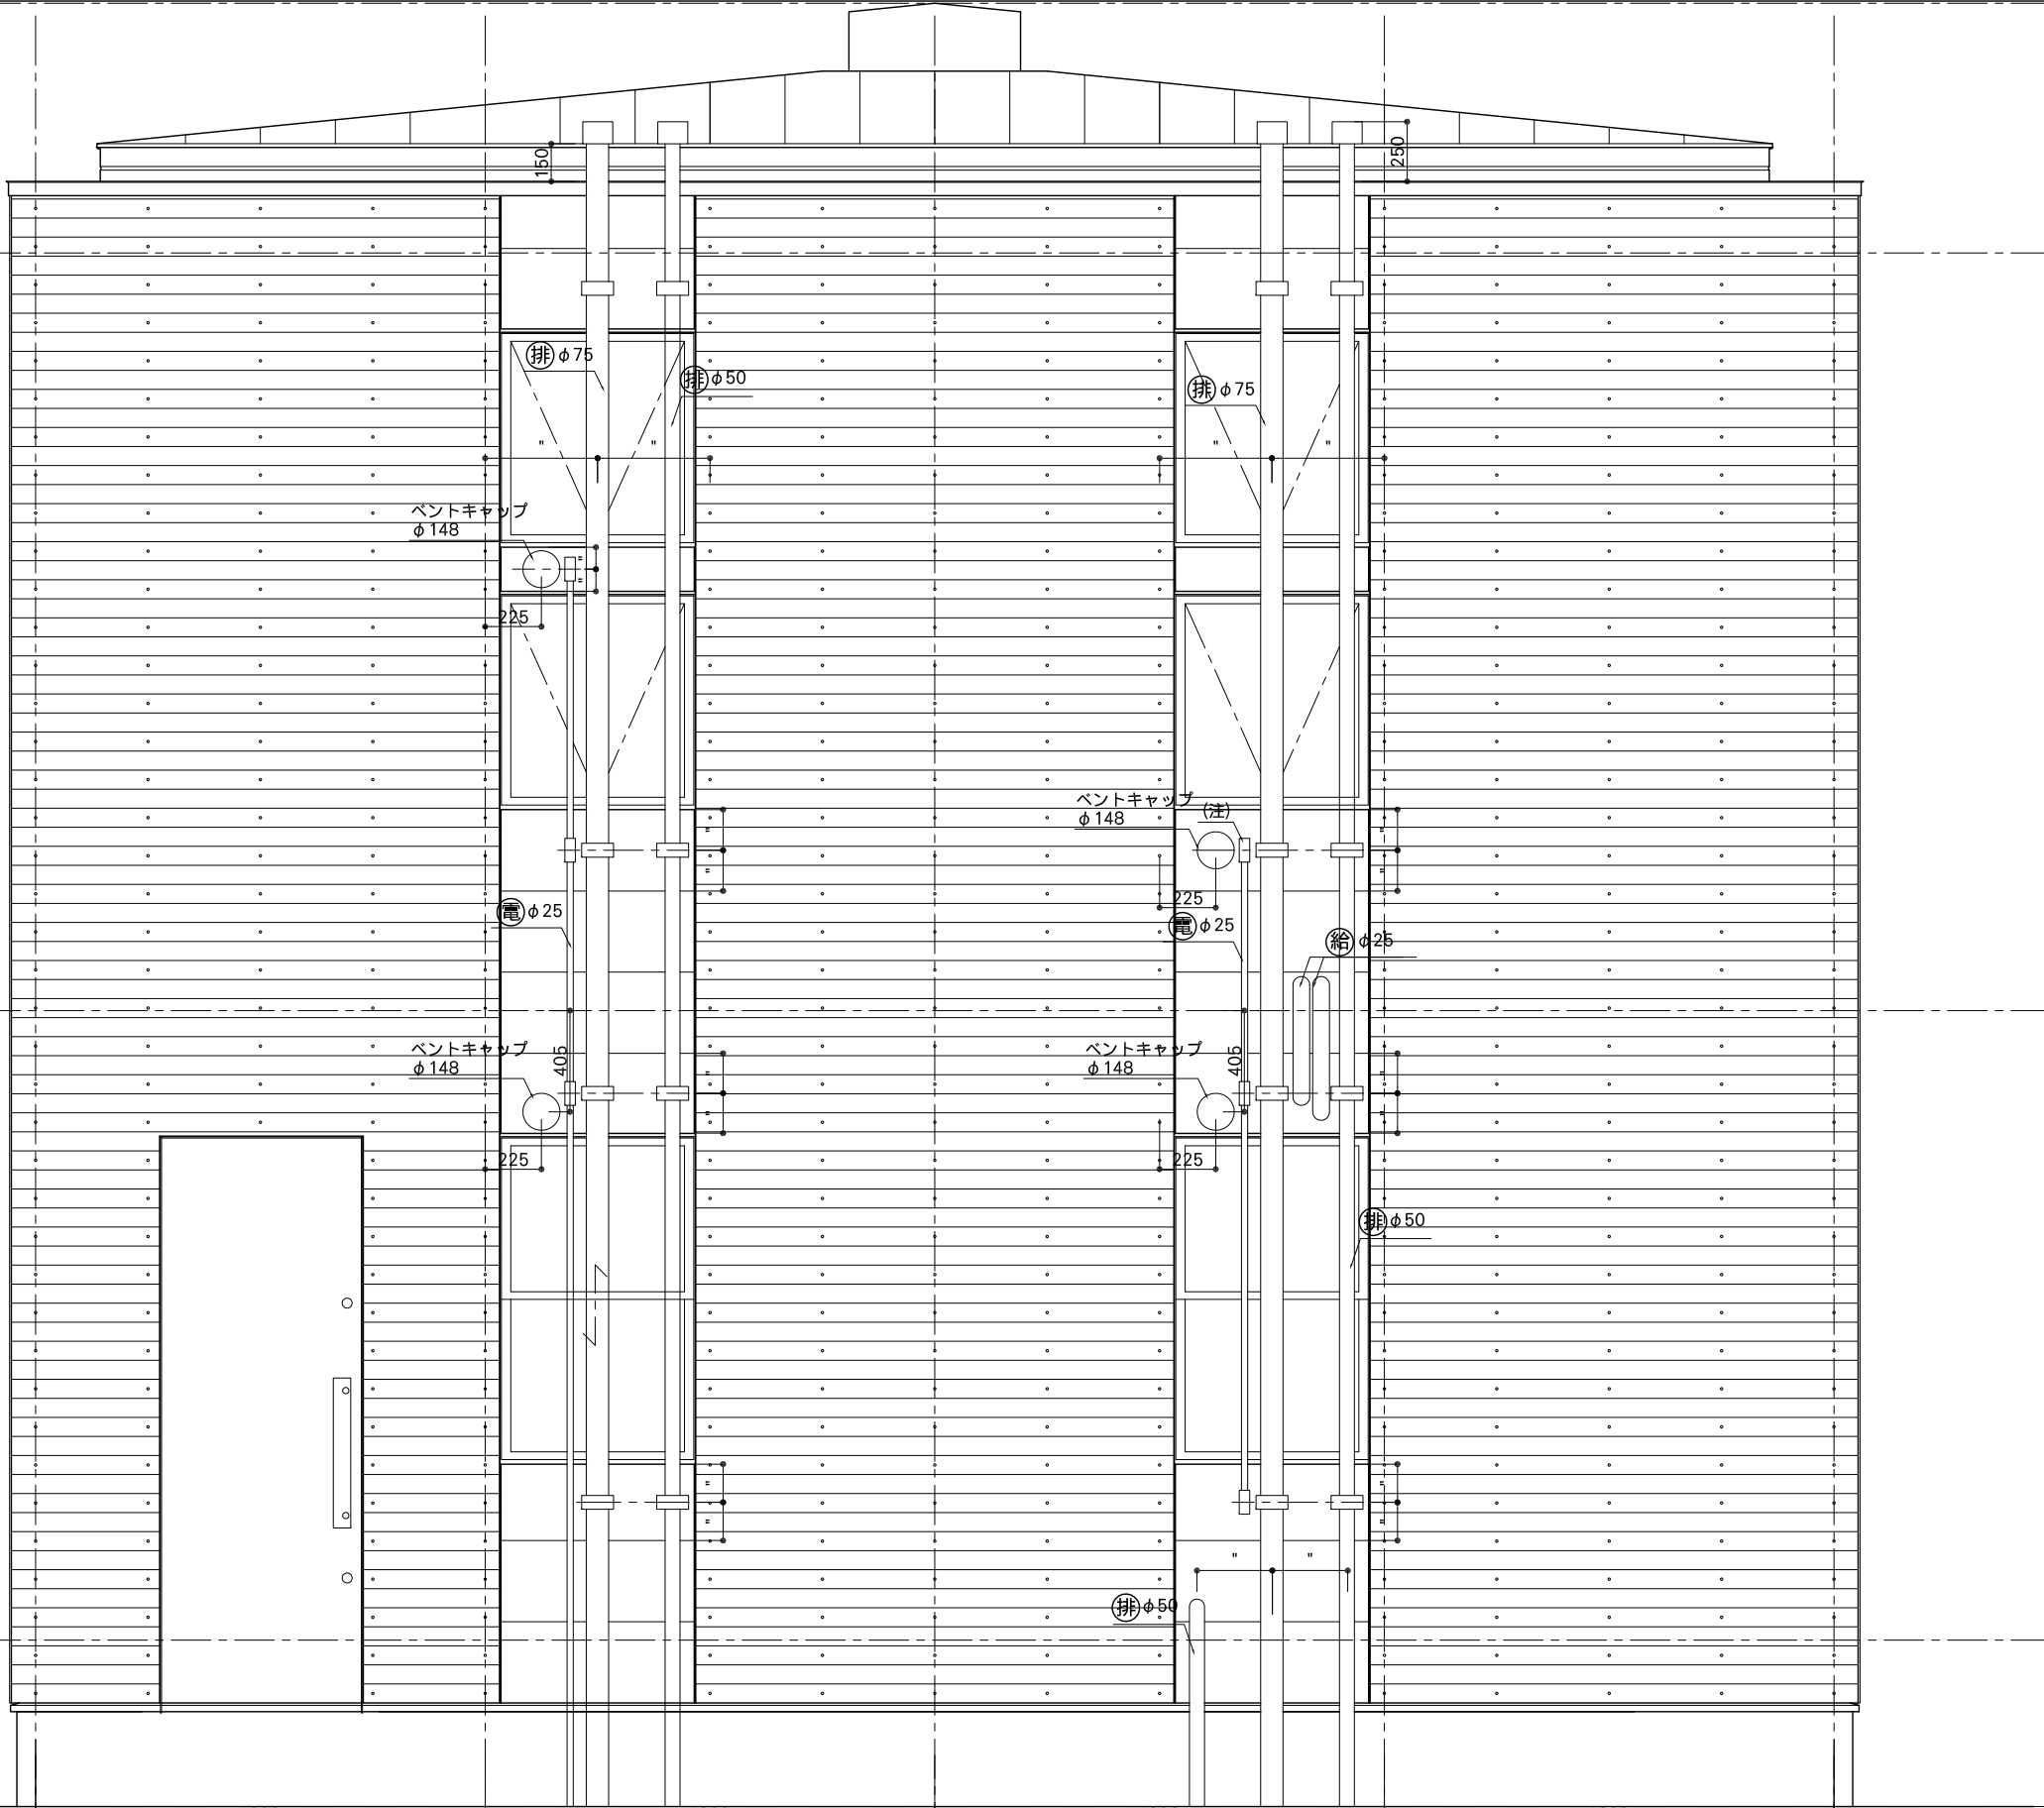

凡例

排水管	排
給水管	給
電気配管	電
弱電	弱

E通り

PROJECT GPLの家		Copyright (C) Levi / architecture License: GPL version 2 or (at your option) any later version		
DATE 2009.3.28	DRAWING TITLE 詳細立面図(1)	SCALE 1/30	NO AD-19	DRAWING BY njun